

TYPICAL DRAWINGS - LAYOUT AND VALVES ARE FOR GUIDANCE ONLY.


Rev	0	A2
Drawn by		
Checked by		
Approved by		
Date	11-05	
Project	00	
Sheet	11-05	

PIPING & INSTRUMENTATION
DIAGRAM
SUPREME STERN TUBE SEALS
IHC LAGERSMIT
 KINDEBOEK HOLLAND

PID-1012

	VALVE, normally closed		LEVEL ALARM LOW (remote)
	VALVE, normally open		LEVEL INDICATOR (local)

--- VENT PIPE
 — LO PIPE

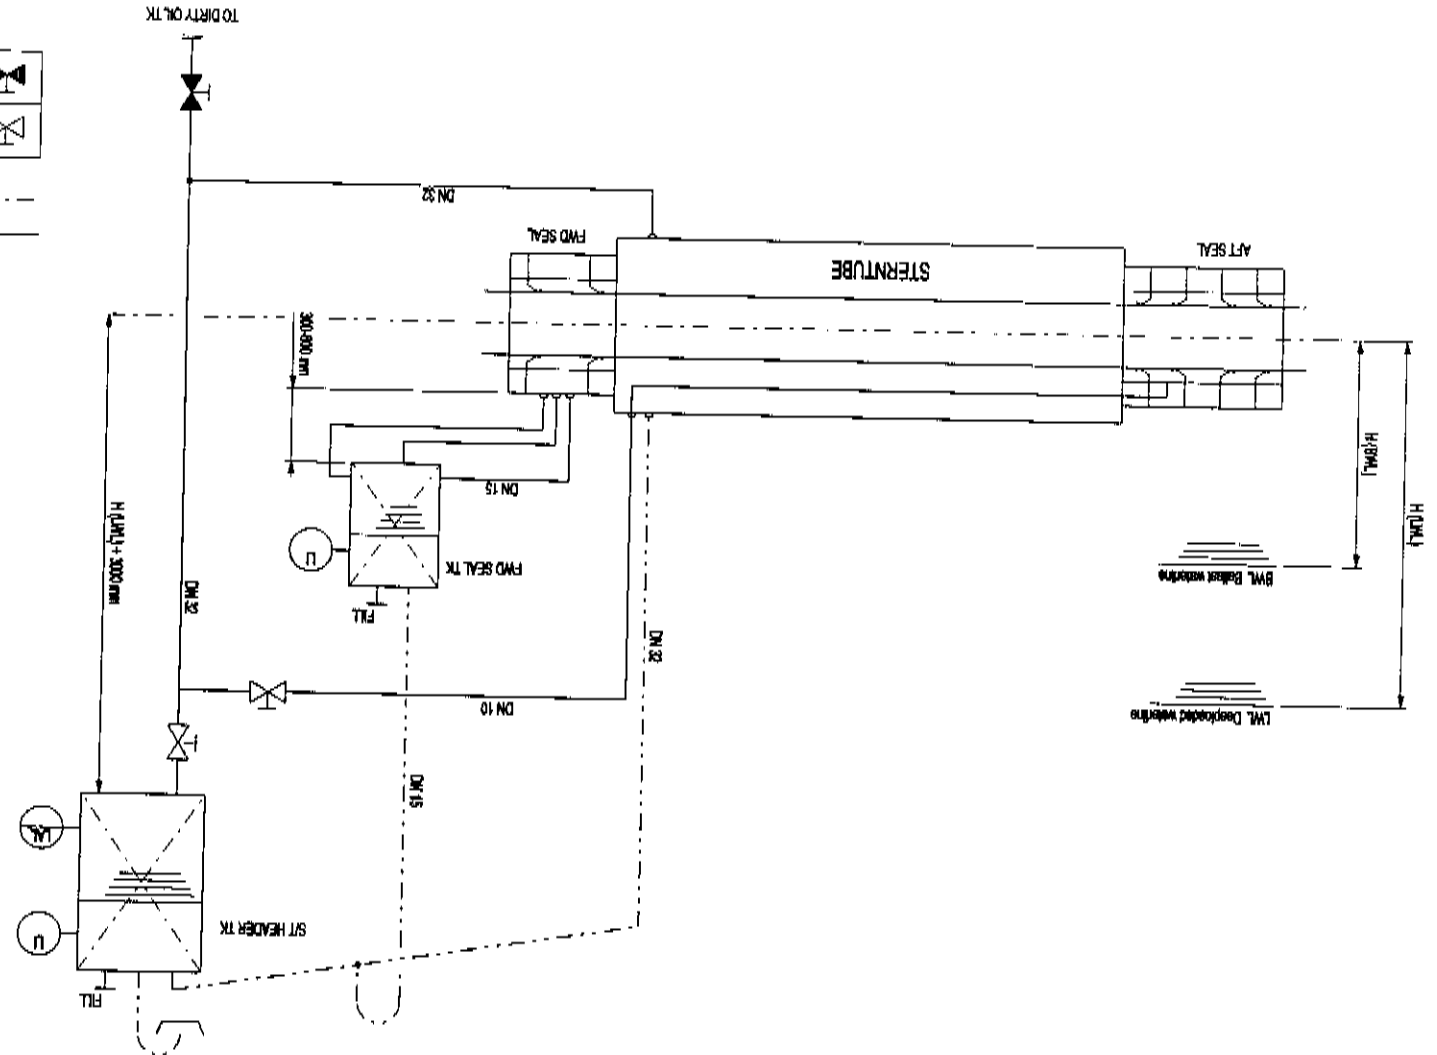

Rev	Description	Original Issue

